


Western Architecture
Design Group, Inc.
 2 West St. George Blvd.
 Ancestor Square Suite 10
 St. George Utah 84770
 435/636-1312 Fax 435-636-1355
 westerndesign@qwest.net

VAN BOERUM & FRANK TESS, INC.
 MECHANICAL ENGINEERS
 1970 W 1600 S, Ste. #104
 St. George, UT 84770
 435.674.4888 T
 435.674.2788 F
 VBFA Project Number: 8108

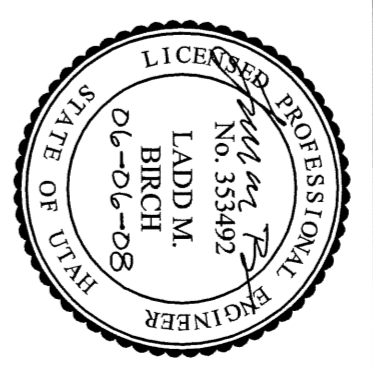


PAINTER'S SERVICE CENTER
 1600 HILTON DR.
 ST. GEORGE, UTAH 84770

JIM PAINTER


PROJECT NO.:	VBFA-8108
MODEL FILE:	
DRAWN BY:	P. FARMSWORTH
CHECKED BY:	L. BIRCH
COPYRIGHT:	
CD	
PP	
DD	//
MARK	DATE DESCRIPTION

SHEET TITLE
PLUMBING DETAILS








SHEET
P0.1
 OF

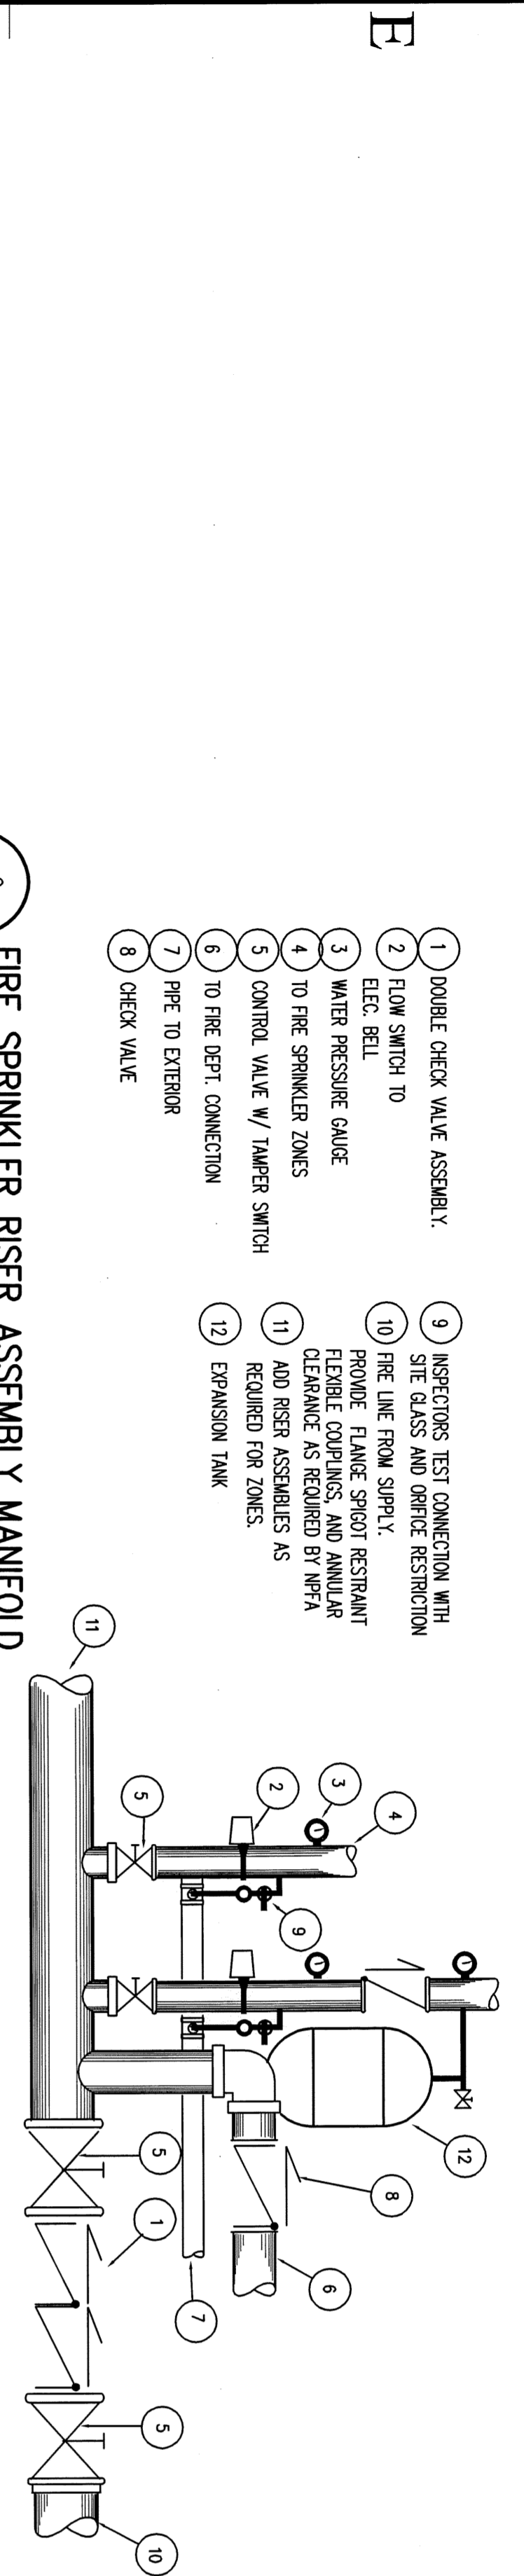

- 1 DOUBLE CHECK VALVE ASSEMBLY
- 2 FLOW SWITCH TO ELEC. BELL
- 3 WATER PRESSURE GAUGE
- 4 TO FIRE SPRINKLER ZONES
- 5 CONTROL VALVE W/ TAMPER SWITCH
- 6 TO FIRE DEPT CONNECTION
- 7 FIRE TO EXTERIOR
- 8 CHECK VALVE
- 9 INSPECTORS TEST CONNECTION WITH SILE CLASS AND GORGE RESTRICTION
- 10 FIRE LINE FROM SUPPLY PROVIDE FLANGE SPOT RESTRAINT CLEARANCE AS REQUIRED BY NFPA
- 11 ADD RISER ASSEMBLY AS REQUIRED FOR ZONES
- 12 EXPANSION TANK

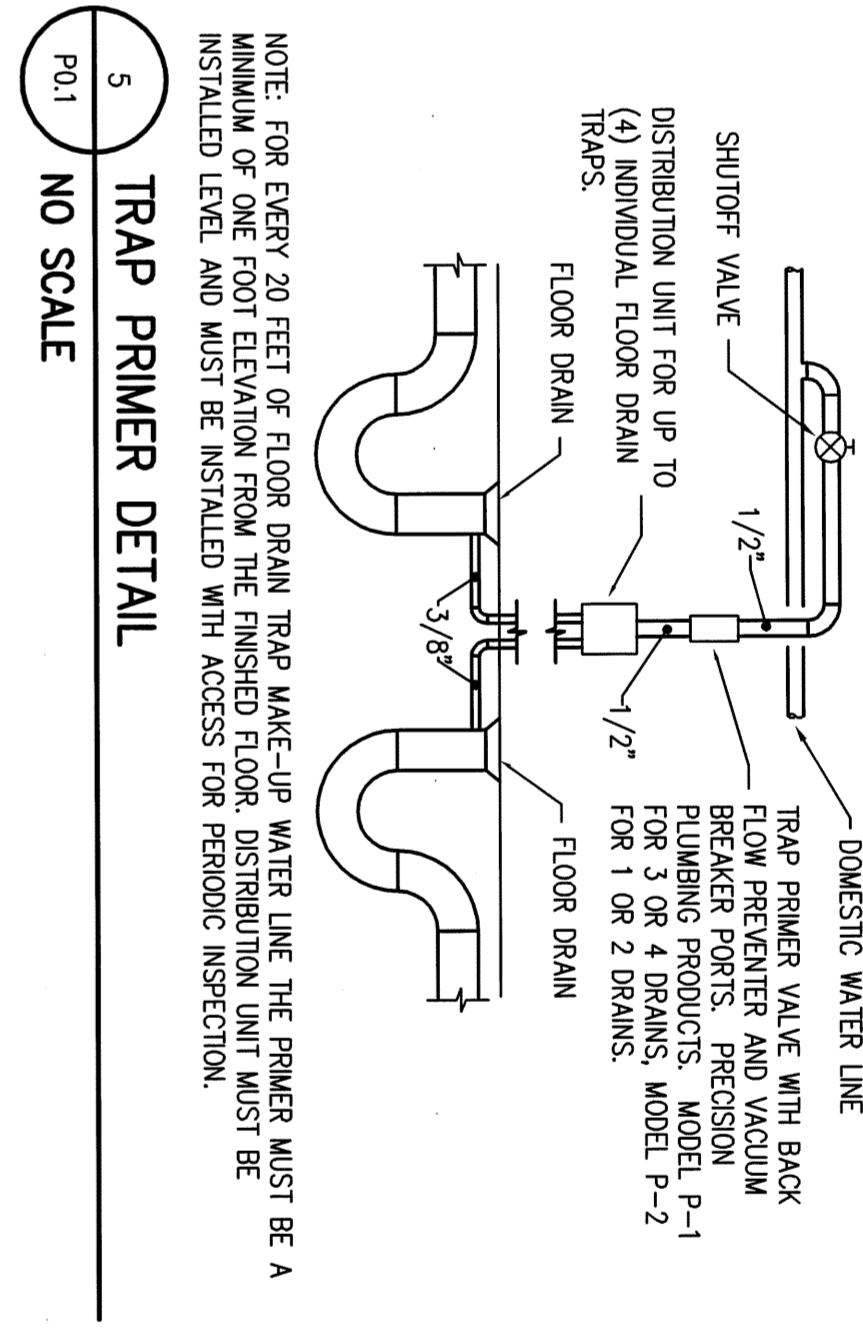

NOTE: FOR EVERY 20 FEET OF FLOOR DRAIN TRAP MAKE-UP WATER LINE THE PRIMER MUST BE A MINIMUM OF ONE FOOT ELEVATION FROM THE FINISHED FLOOR. DISTRIBUTION UNIT MUST BE INSTALLED ON ONE LEVEL AND MUST BE INSTALLED WITH ACCESS FOR PERIODIC INSPECTION.

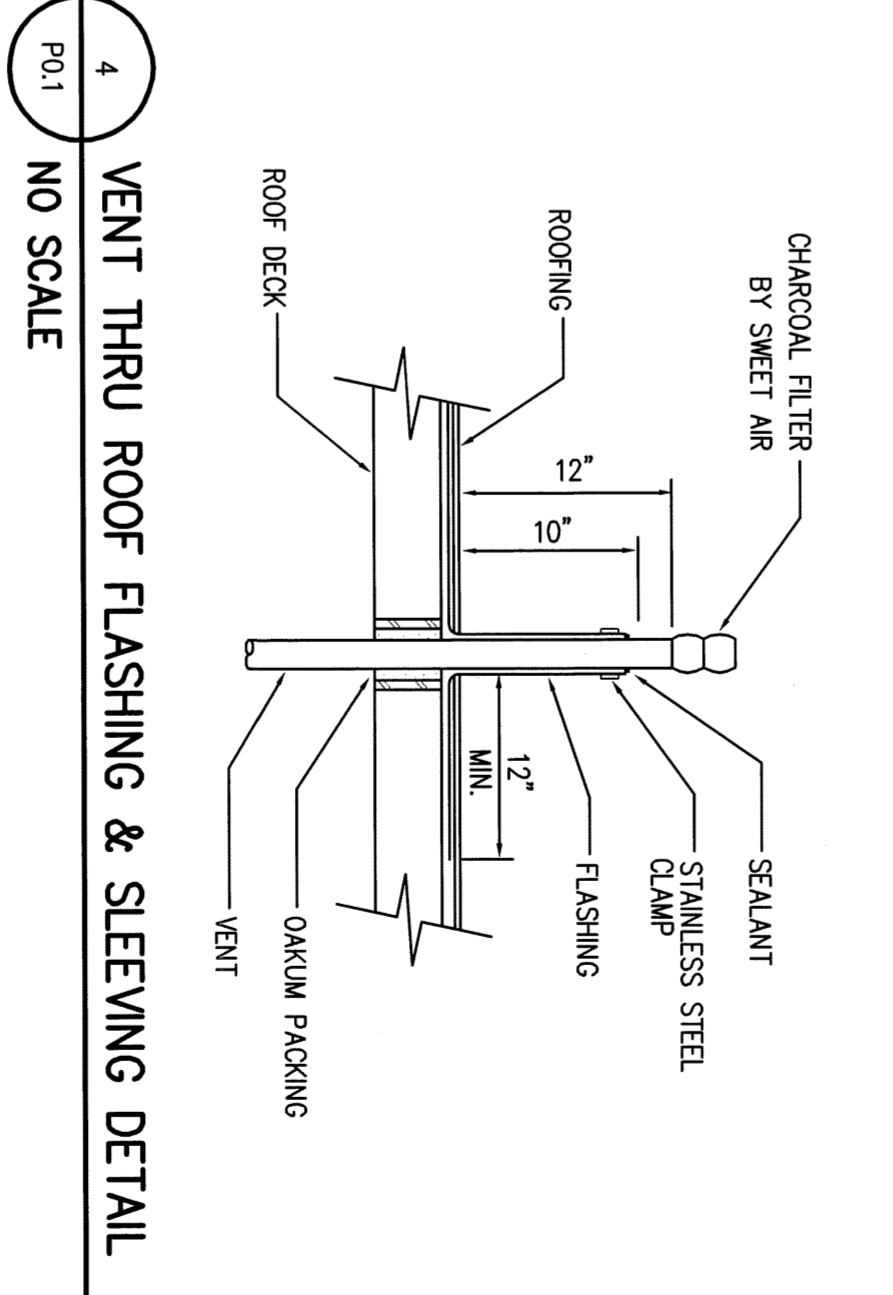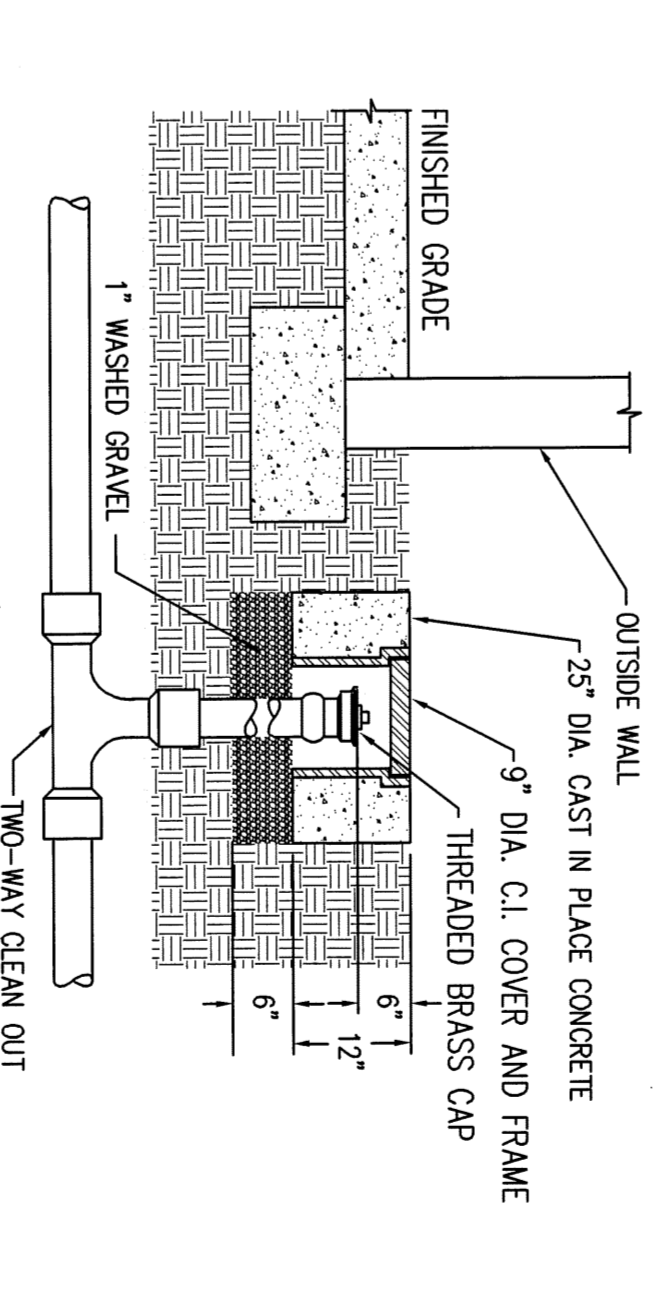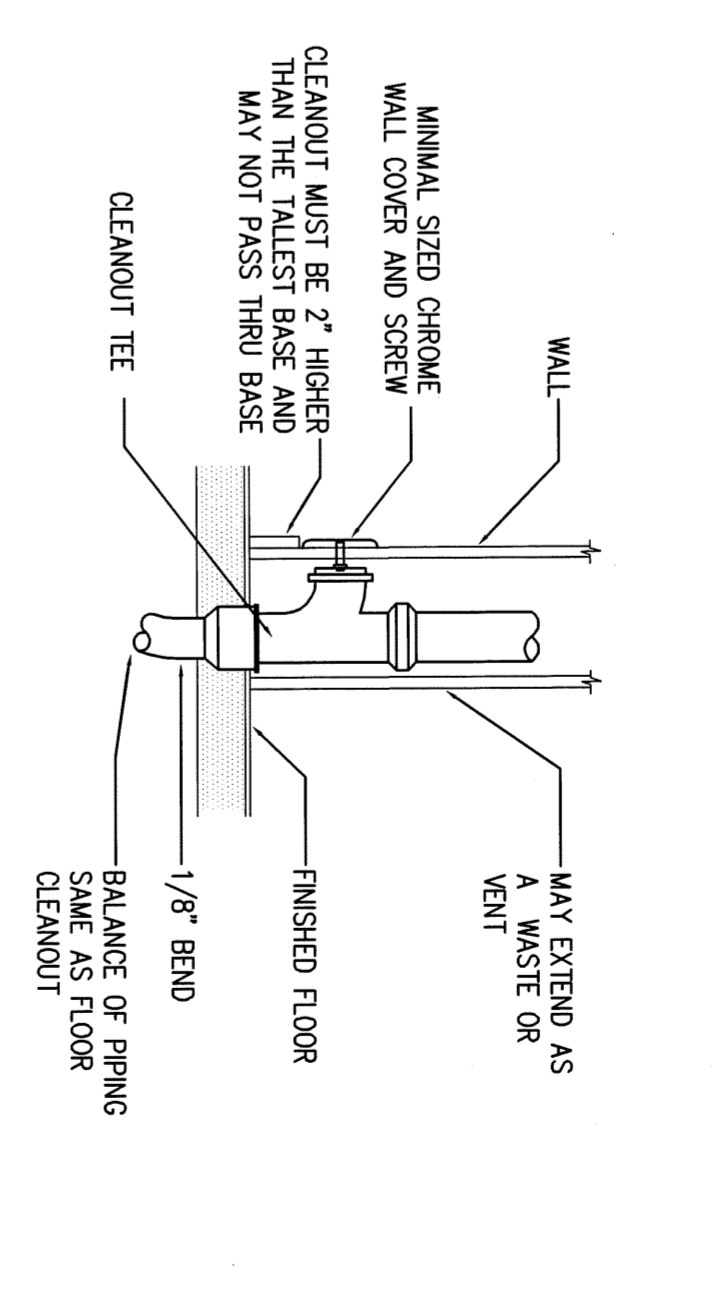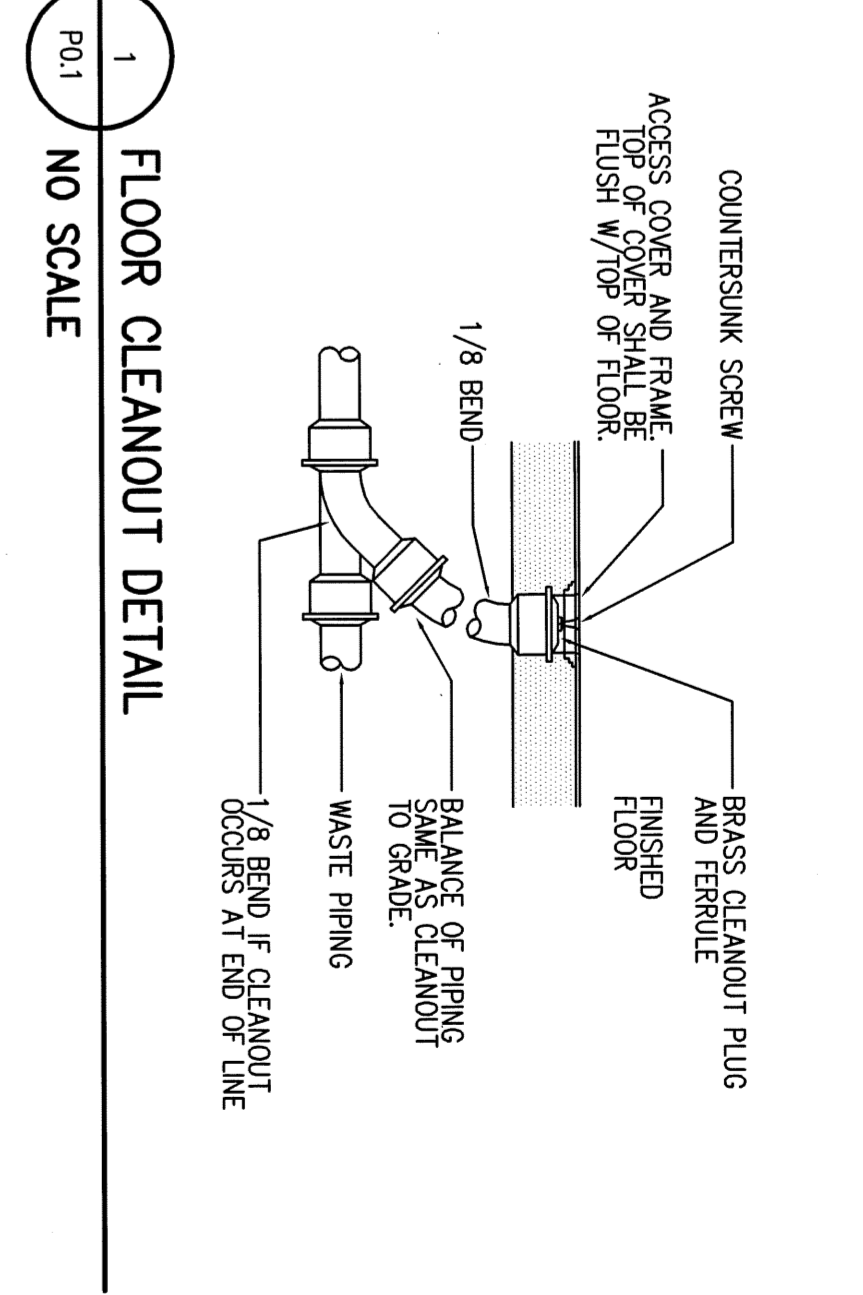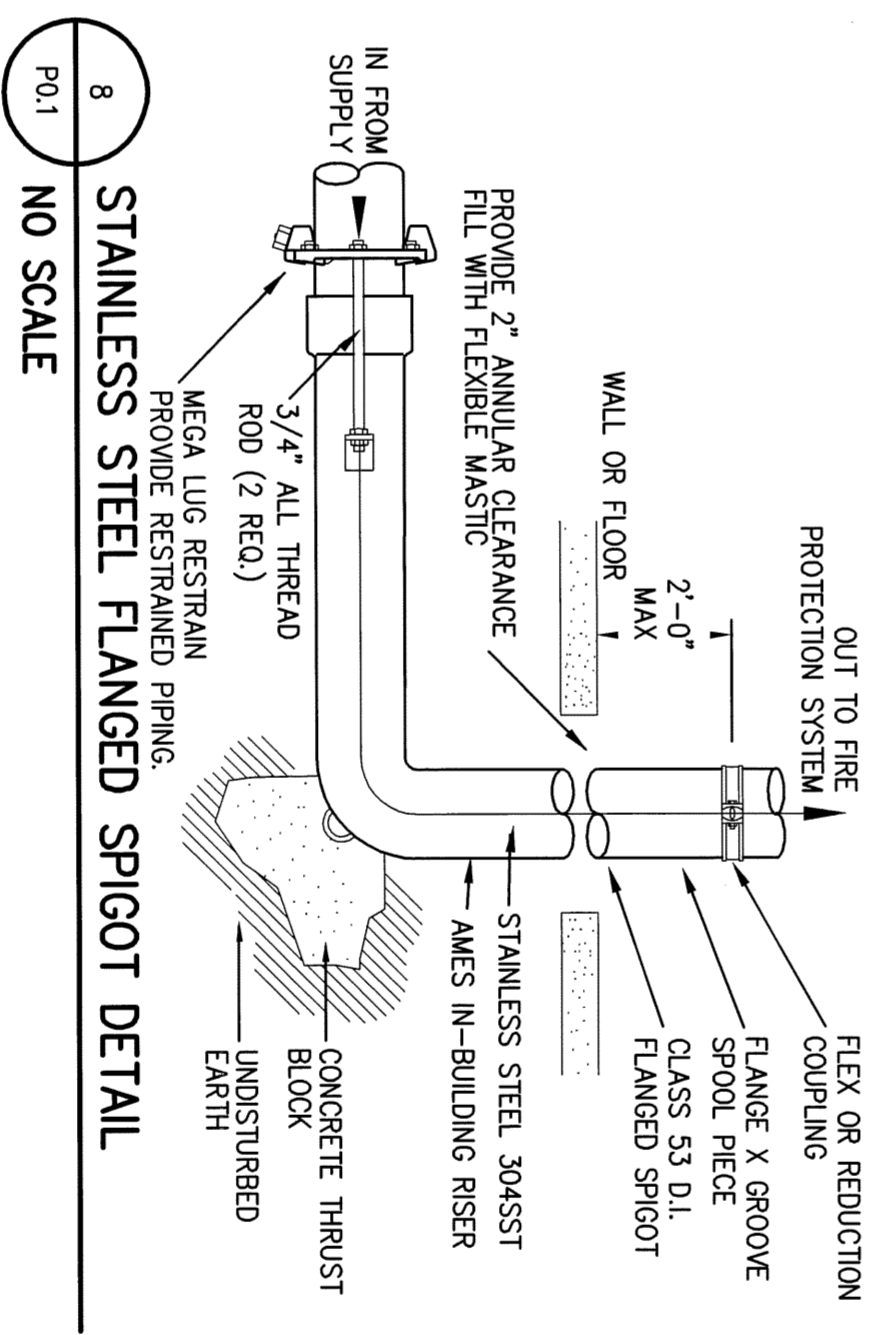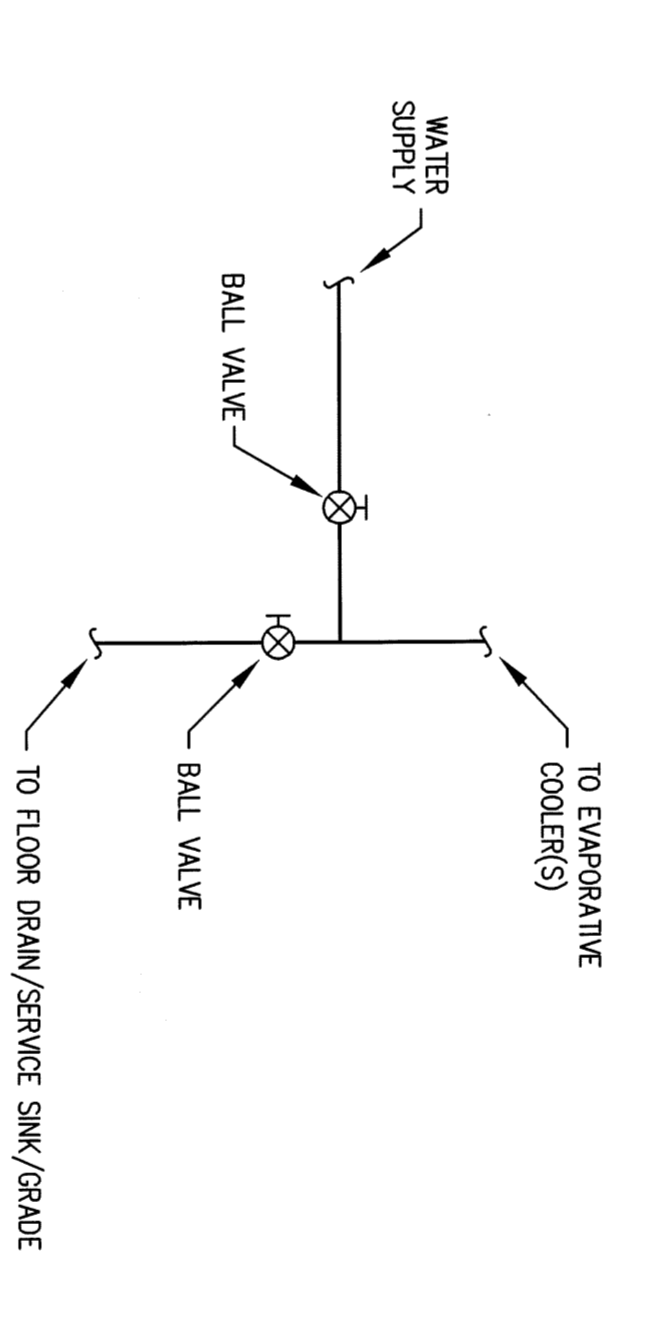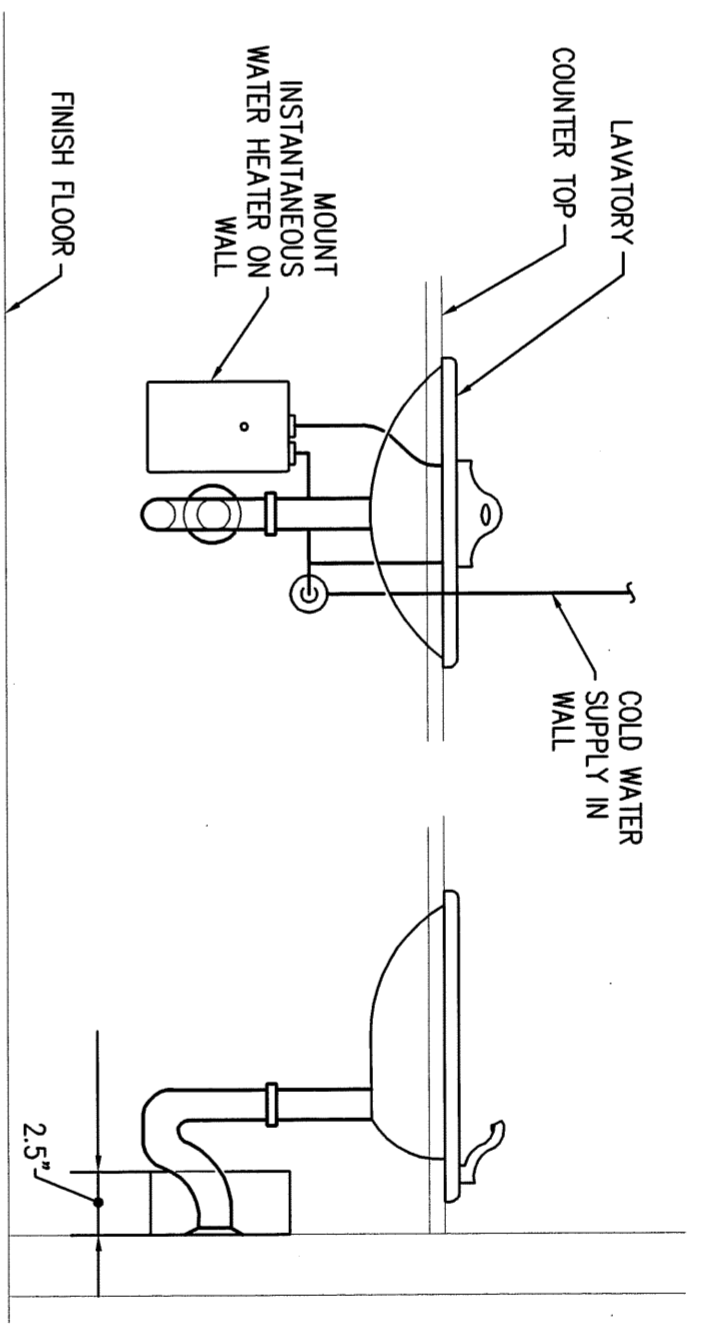

1 2 3 4 5 6

A B C D E