



SCALE: 1/8" = 1'-0"  
 PLUMBING PLAN  
 AREA: D MAIN LEVEL

**# KEYED NOTES**  
 1. SEE CIVIL SITE UTILITY PLAN FOR CONTINUATION.

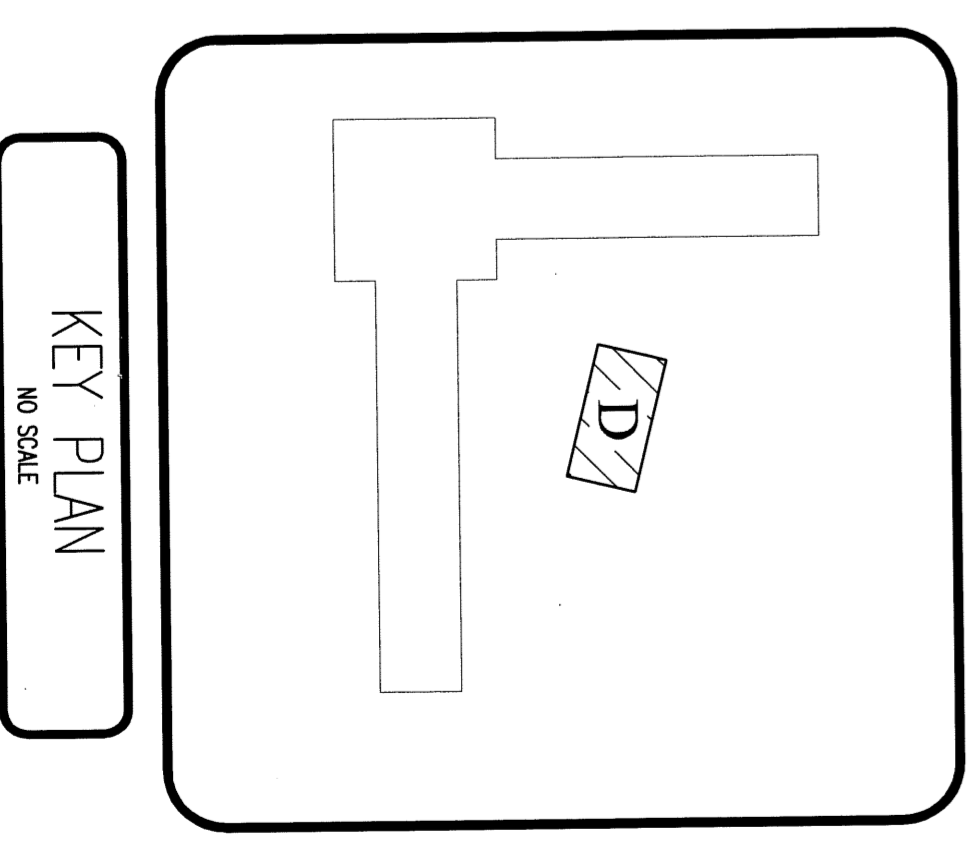

**Western** ARCHITECTURE  
**Design Group, Inc.**  
 2 West St. George Blvd.  
 Ancestor Square Suite 10  
 St. George Utah 84770  
 435/656-1312 Fax 656-1355  
 westerdsgn@qwest.net

**CONSULTANTS**  
**VAN ROERUM**  
**ATTARAK & ASSOCIATES INC.**  
 1070 W 1600 S, Ste. #104  
 St. George, UT 84710  
 435/744-8001  
 435/744-2100 F  
 VERA Project Number: 2108

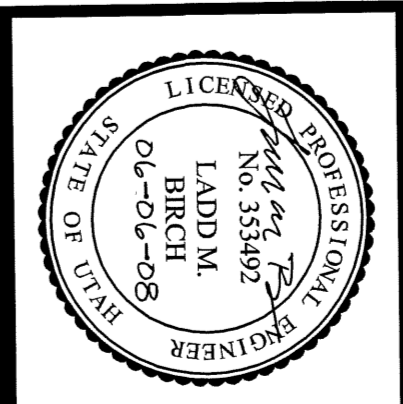

**PAINTER'S SERVICE CENTER**  
 1600 HILTON DR.  
 ST. GEORGE, UTAH 84770

JIM PAINTER

| MARK | DATE | DESCRIPTION |
|------|------|-------------|
| CD   |      |             |
| PP   |      |             |
| DD   | //   |             |

PROJECT NO: VBF-A-8108  
 MODEL FILE:  
 DRAWN BY: P.FRANSWORTH  
 CHK'D BY: L.BIRCH  
 COPY/RIGHT:

SHEET TITLE  
 PLUMBING PLAN  
 AREA D & E  
 MAIN LEVEL  
**P1.2**  
 SHEET OF